
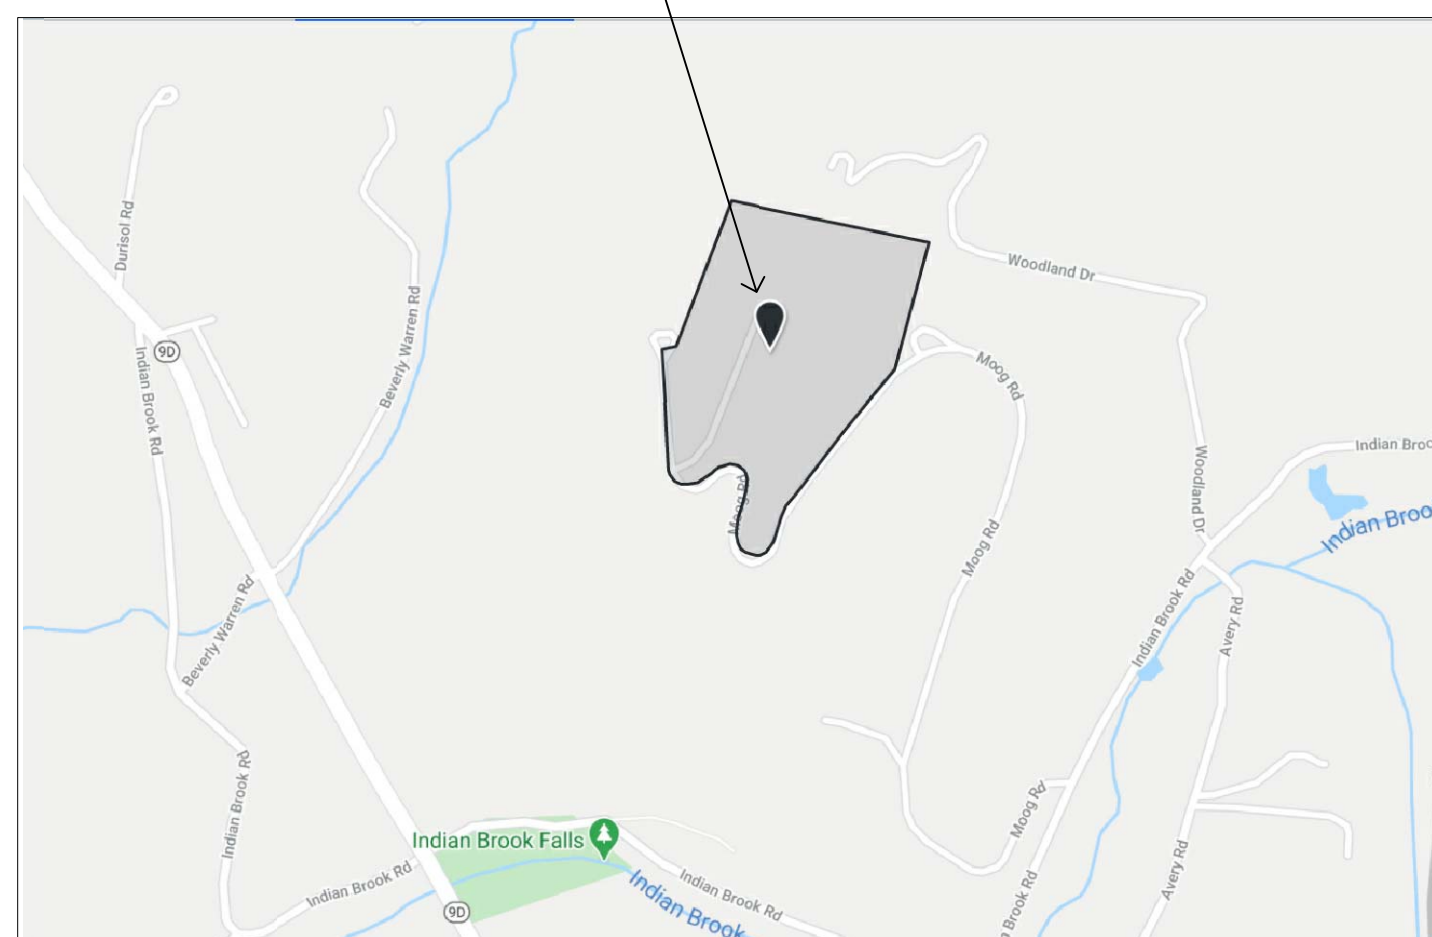


VICINITY MAP

SITE LOCATION:
176 MOOG ROAD
GARRISON, NY 10524

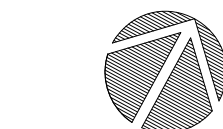

PROJECT DIRECTORY

OWNER:
CARLOS PICON & ANDREW KEPLER
176 MOOG ROAD
GARRISON,
NY, 10524

LANDSCAPE ARCHITECT:
DAVID EATON ASSOCIATES
578 STERLING PL., STE 1
BROOKLYN, NY 11238
T (347) 233-1519

SURVEYOR:
BADEY & WATSON,
Surveying and Engineering, P.C.
3063 U.S. Route 9
Cold Spring, NY 10516
T (845) 265-9217

BUILDING CONTRACTOR:
TBD

LANDSCAPE CONTRACTOR:
TBD

DRAWING INDEX

L-100 DRAWING SERIES		GENERAL
Drawing Number	Drawing Title	Drawing Scale
L-001	Title Sheet	N/A
L-002	Demolition Plan	1/8" = 1'-0"
L-101	Site Plan	NTS
L-102	Enlarged Plan - Courtyard and Arrival Court	1/8" = 1'-0"
L-103	Grading and Drainage Plan - Courtyard and Arrival Court	1/8" = 1'-0"
L-104	Lighting Plan	1/8" = 1'-0"

L-200 DRAWING SERIES		PLANTING PLANS
Drawing Number	Drawing Title	Drawing Scale
L-200	Key Plan	N/A
L-201	North Garden	1/8" = 1'-0"
L-202	Courtyard and Arrival Court	1/8" = 1'-0"
L-203	South Garden	1/8" = 1'-0"
L-204	Drive Entrance II	1/8" = 1'-0"
L-205	Drive Entrance I	1/8" = 1'-0"

L-300 DRAWING SERIES		SECTIONS & ELEVATIONS
Drawing Number	Drawing Title	Drawing Scale
L-300	Elevations Location Plan	N/A
L-301	Elevations A'-A", B'-B"	3/16" = 1'-0"
L-302	Elevations C'-C", D'-D"	3/16" = 1'-0"
L-303	Elevations E'-E", F'-F"	3/16" = 1'-0"
L-304	Elevations G'-G", H'-H", I'-I"	3/16" = 1'-0"

L-400 DRAWING SERIES		DETAILS
Drawing Number	Drawing Title	Drawing Scale
L-401	Details - Pergola	Varies
L-402	Details - Reflecting Pool	Varies
L-403	Details - Walls & Paving	Varies

L-500 DRAWING SERIES		BUILDING EXTENSION SCHEMATICS
Drawing Number	Drawing Title	Drawing Scale
L-501	Garage and North and South Entrance Details	Varies
L-502	Details - Reflecting Pool	Varies

A Issued to Building Dept DE 09/03/20
REV DESCRIPTION APP. DATE



DAVID EATON ASSOCIATES
578 STERLING PLACE
BROOKLYN, NY, 11238

176 Moog Road,
Garrison

TITLE SHEET

DATE 07/29/2019 STATUS DRAFT
SCALE N/A DRAWN FF
DWG. NO L_001 APPROVED DE